


POTHOLING PLAN		
Description	Quantity	
● Pothole - Additional	11	
● Pothole - Base Bid	3	

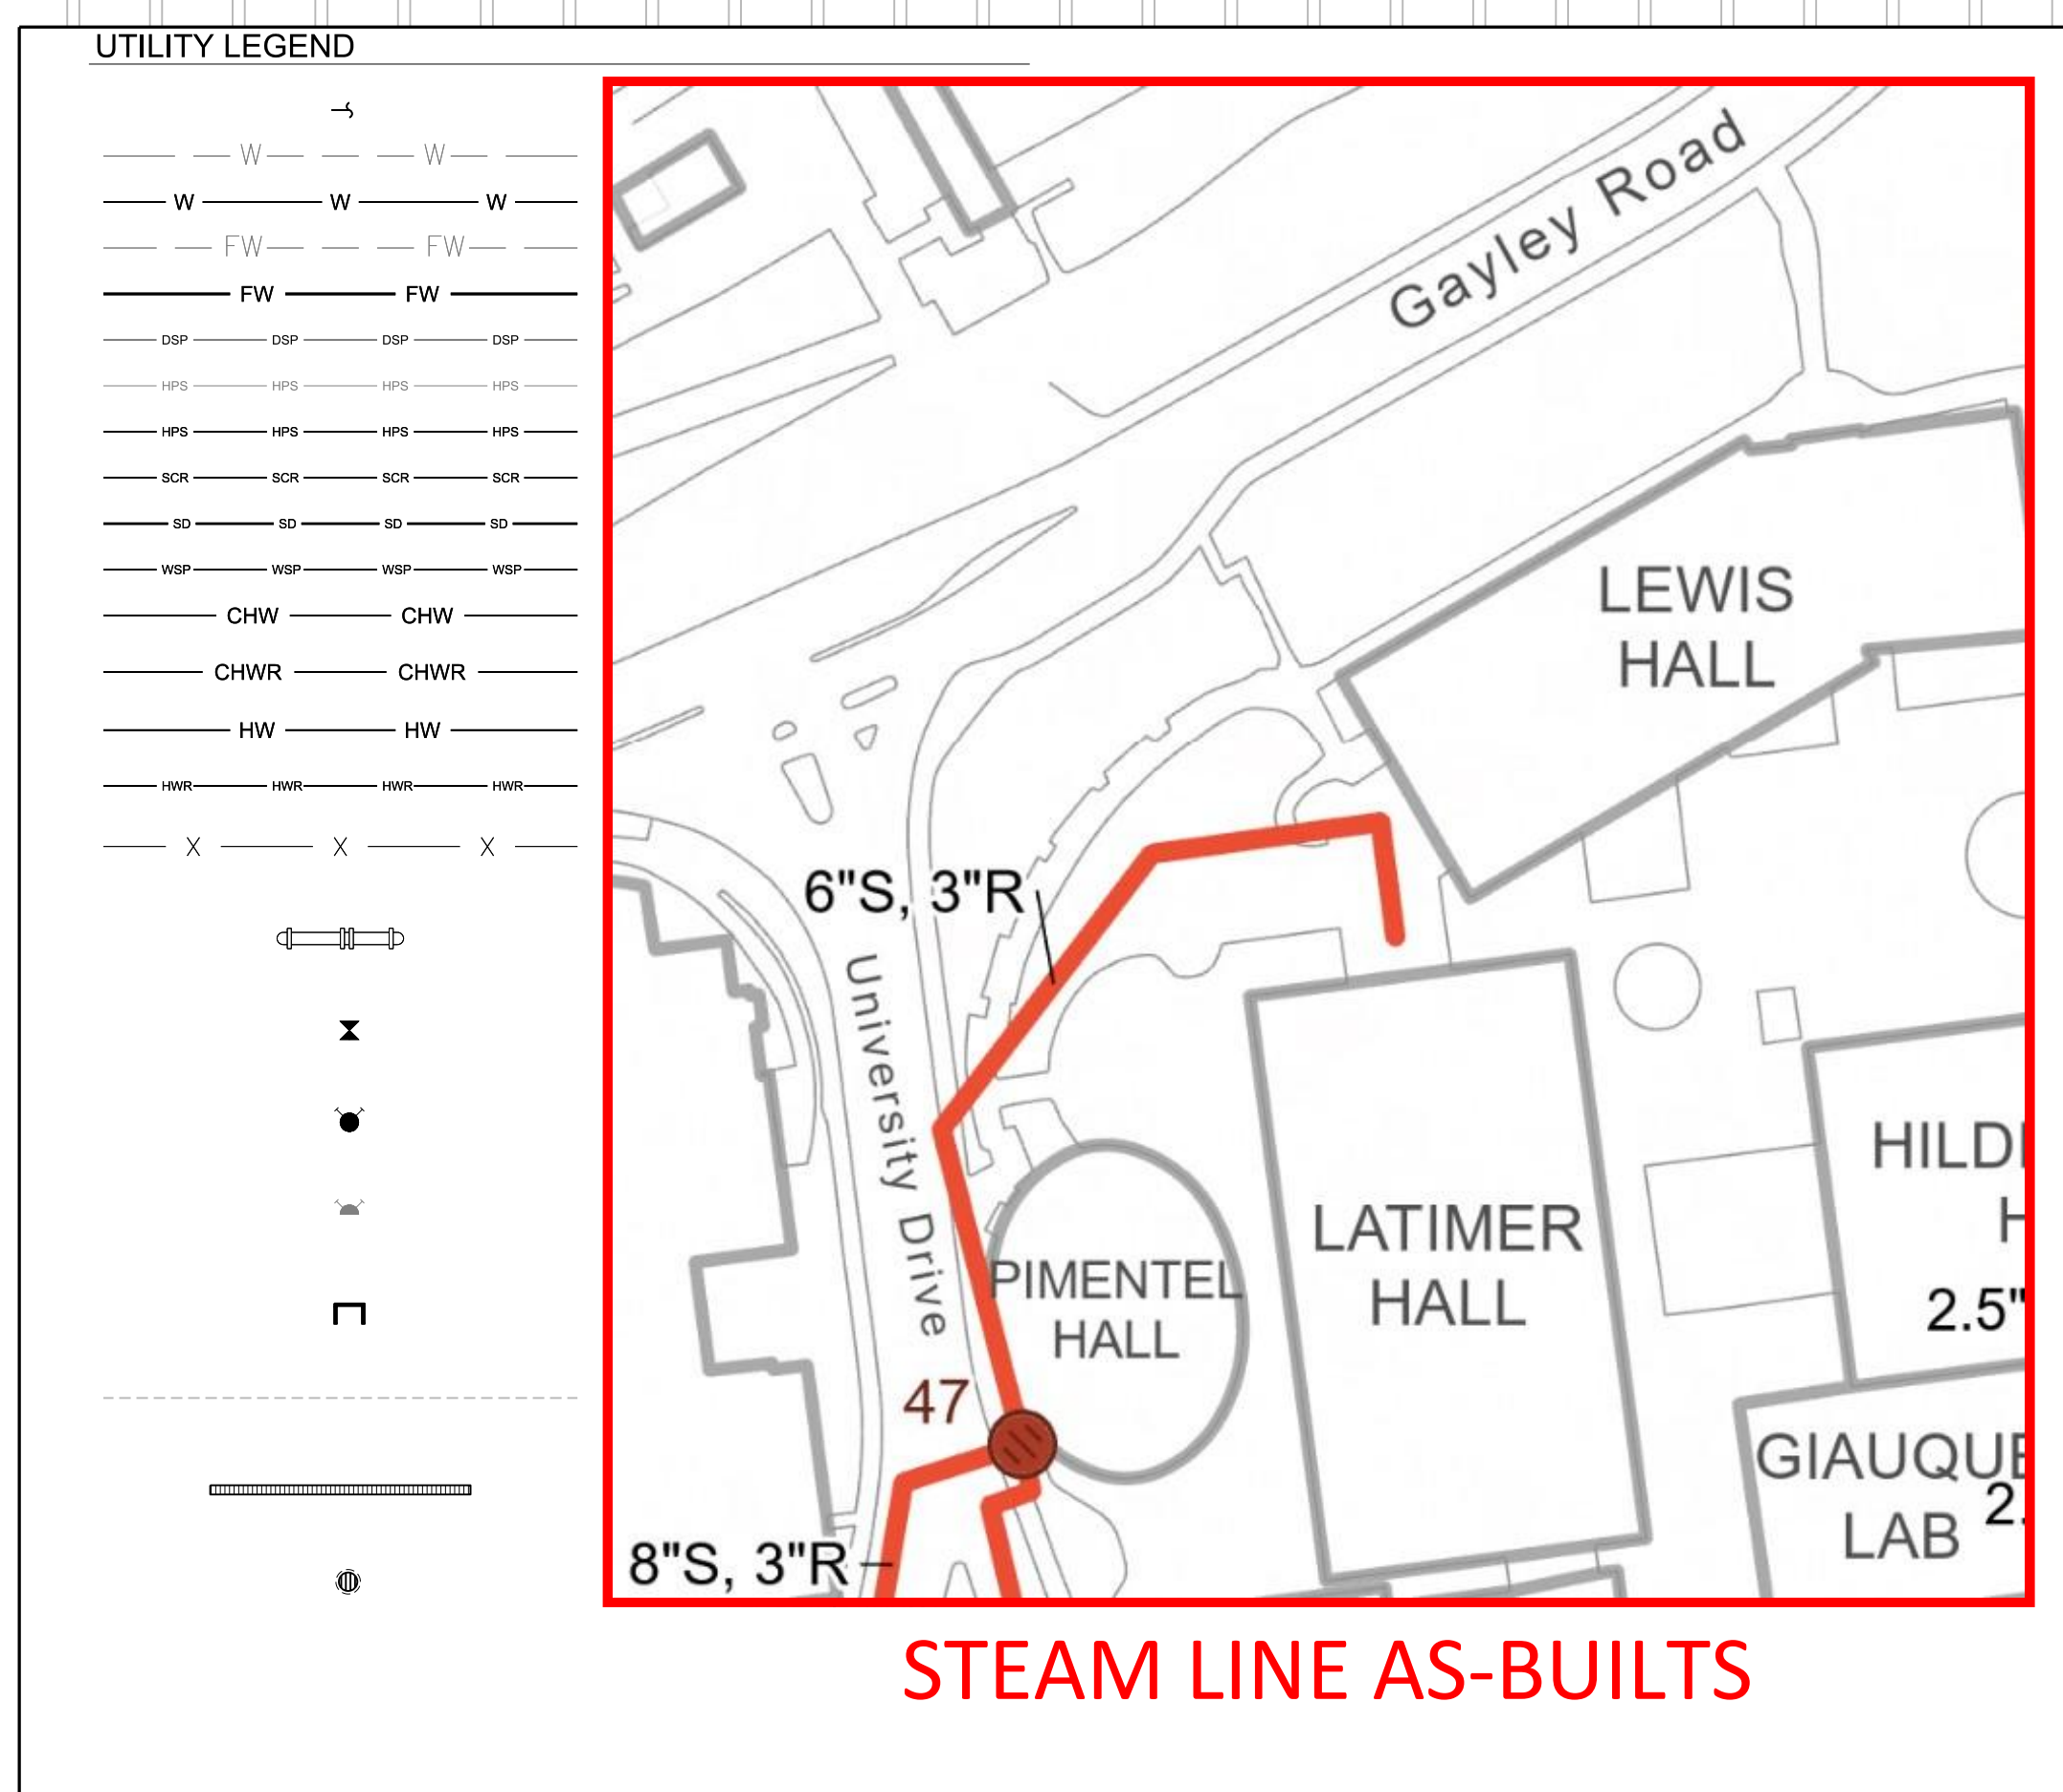

STEAM LINE AS-BUILTS

MAKE READY

Berkeley


Project
HEATHCOCK HALL
University Drive
University of California, Berkeley
Berkeley, CA 94720

Prepared For
Capital Projects
1936 University Ave, 2nd Floor
University of California, Berkeley
Berkeley, CA 94704



Hellmuth, Obata & Kassabaum, Inc.
Architecture, Landscape, Lab Planning, Interiors
One Bush Street, Suite 200
San Francisco, CA 94104 USA
t +1 415 243 0555 f +1 415 882 7763

- In Association with
- Forell Esesser Engineers Inc.
Structural Engineer
160 Pine Street, Suite 600
San Francisco, CA 94111
 - Vanderweil Engineers Inc.
MEP/EIR Engineers
274 Summer Street
Boston, MA 02210
 - Sherwood Design Engineers
Civil Engineers
2548 Mission Street
San Francisco, CA 94110
 - Electrolight San Francisco
Lighting Design
329 Bryant Street, Suite 3B
San Francisco, CA 94107
 - Syska Hennessy Group
Vertical Transport
444 Flower Street, Suite 2000
Los Angeles, CA 90071
 - GHD
Code Consultant
2300 Clayton Road, Suite 920
Concord, CA 95407
 - Simpson Gumpertz & Heger
Waterproofing Consultant
1999 Harrison Street, Suite 2400
Oakland, CA 94612
 - SRS Safety Services, Inc.
Window Washing Consultant
220 Wight Brothers Ave.
Livermore, CA 94551

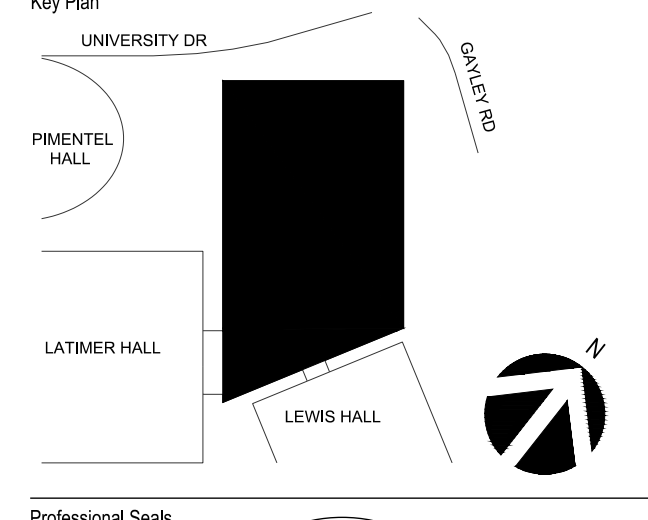

No.	Description	Date
1	Final Schematic Design	04-14-2023
2	Final Design Development	11-03-2023
3	Shoring Design Bid Package	12-05-2023
4	Make Ready	12-15-2023
5	Make Ready Addendum	04-12-2024

Project No: 23-018
Sheet Title:

UTILITY PLAN

Originals at 1/8" = 1'-0". Do not scale contents of this drawing.
Sheet Number

MR400

